
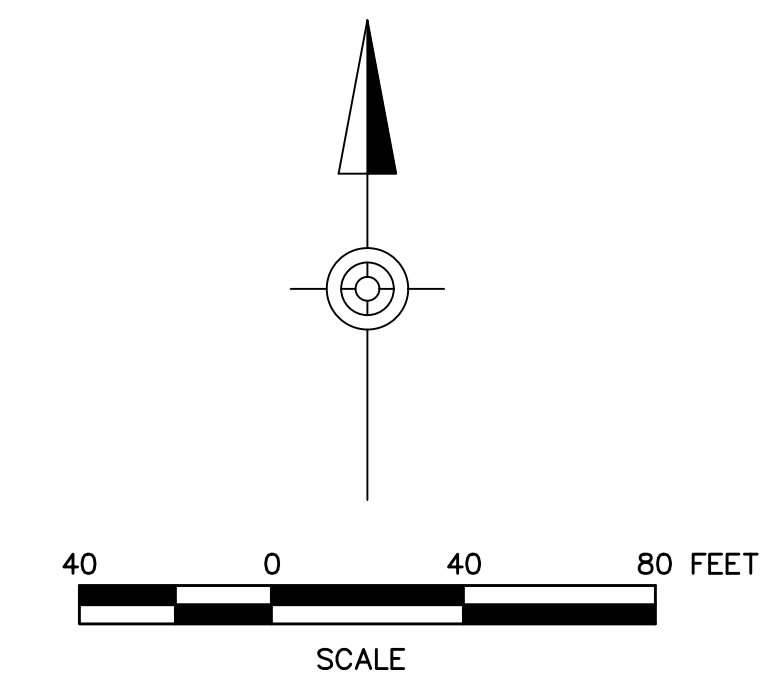


NOTE: GRADING AND UTILITY PLAN, INCLUDING STORMWATER IMPROVEMENTS SHOWN AS PREPARED BY CIVIL AND ENVIRONMENTAL CONSULTANTS, INC. (CEC). DATED JUNE 2021

**UTILITY / SERVICE TABLE**

UTILITY / SERVICE	PROVIDER
ELECTRIC	APS
GAS	SOUTHWEST GAS
IRRIGATION	N/A
WATER	EPCOR
SANITARY SEWER	EPCOR
STORM SEWER	MARICOPA COUNTY
COMMUNICATIONS	COX COMMUNICATIONS
TELEPHONE	CENTURYLINK
FIRE PROTECTION	ARIZONA FIRE AND MEDICAL AUTHORITY
LAW ENFORCEMENT	MARICOPA COUNTY
REFUSE	REPUBLIC SERVICES

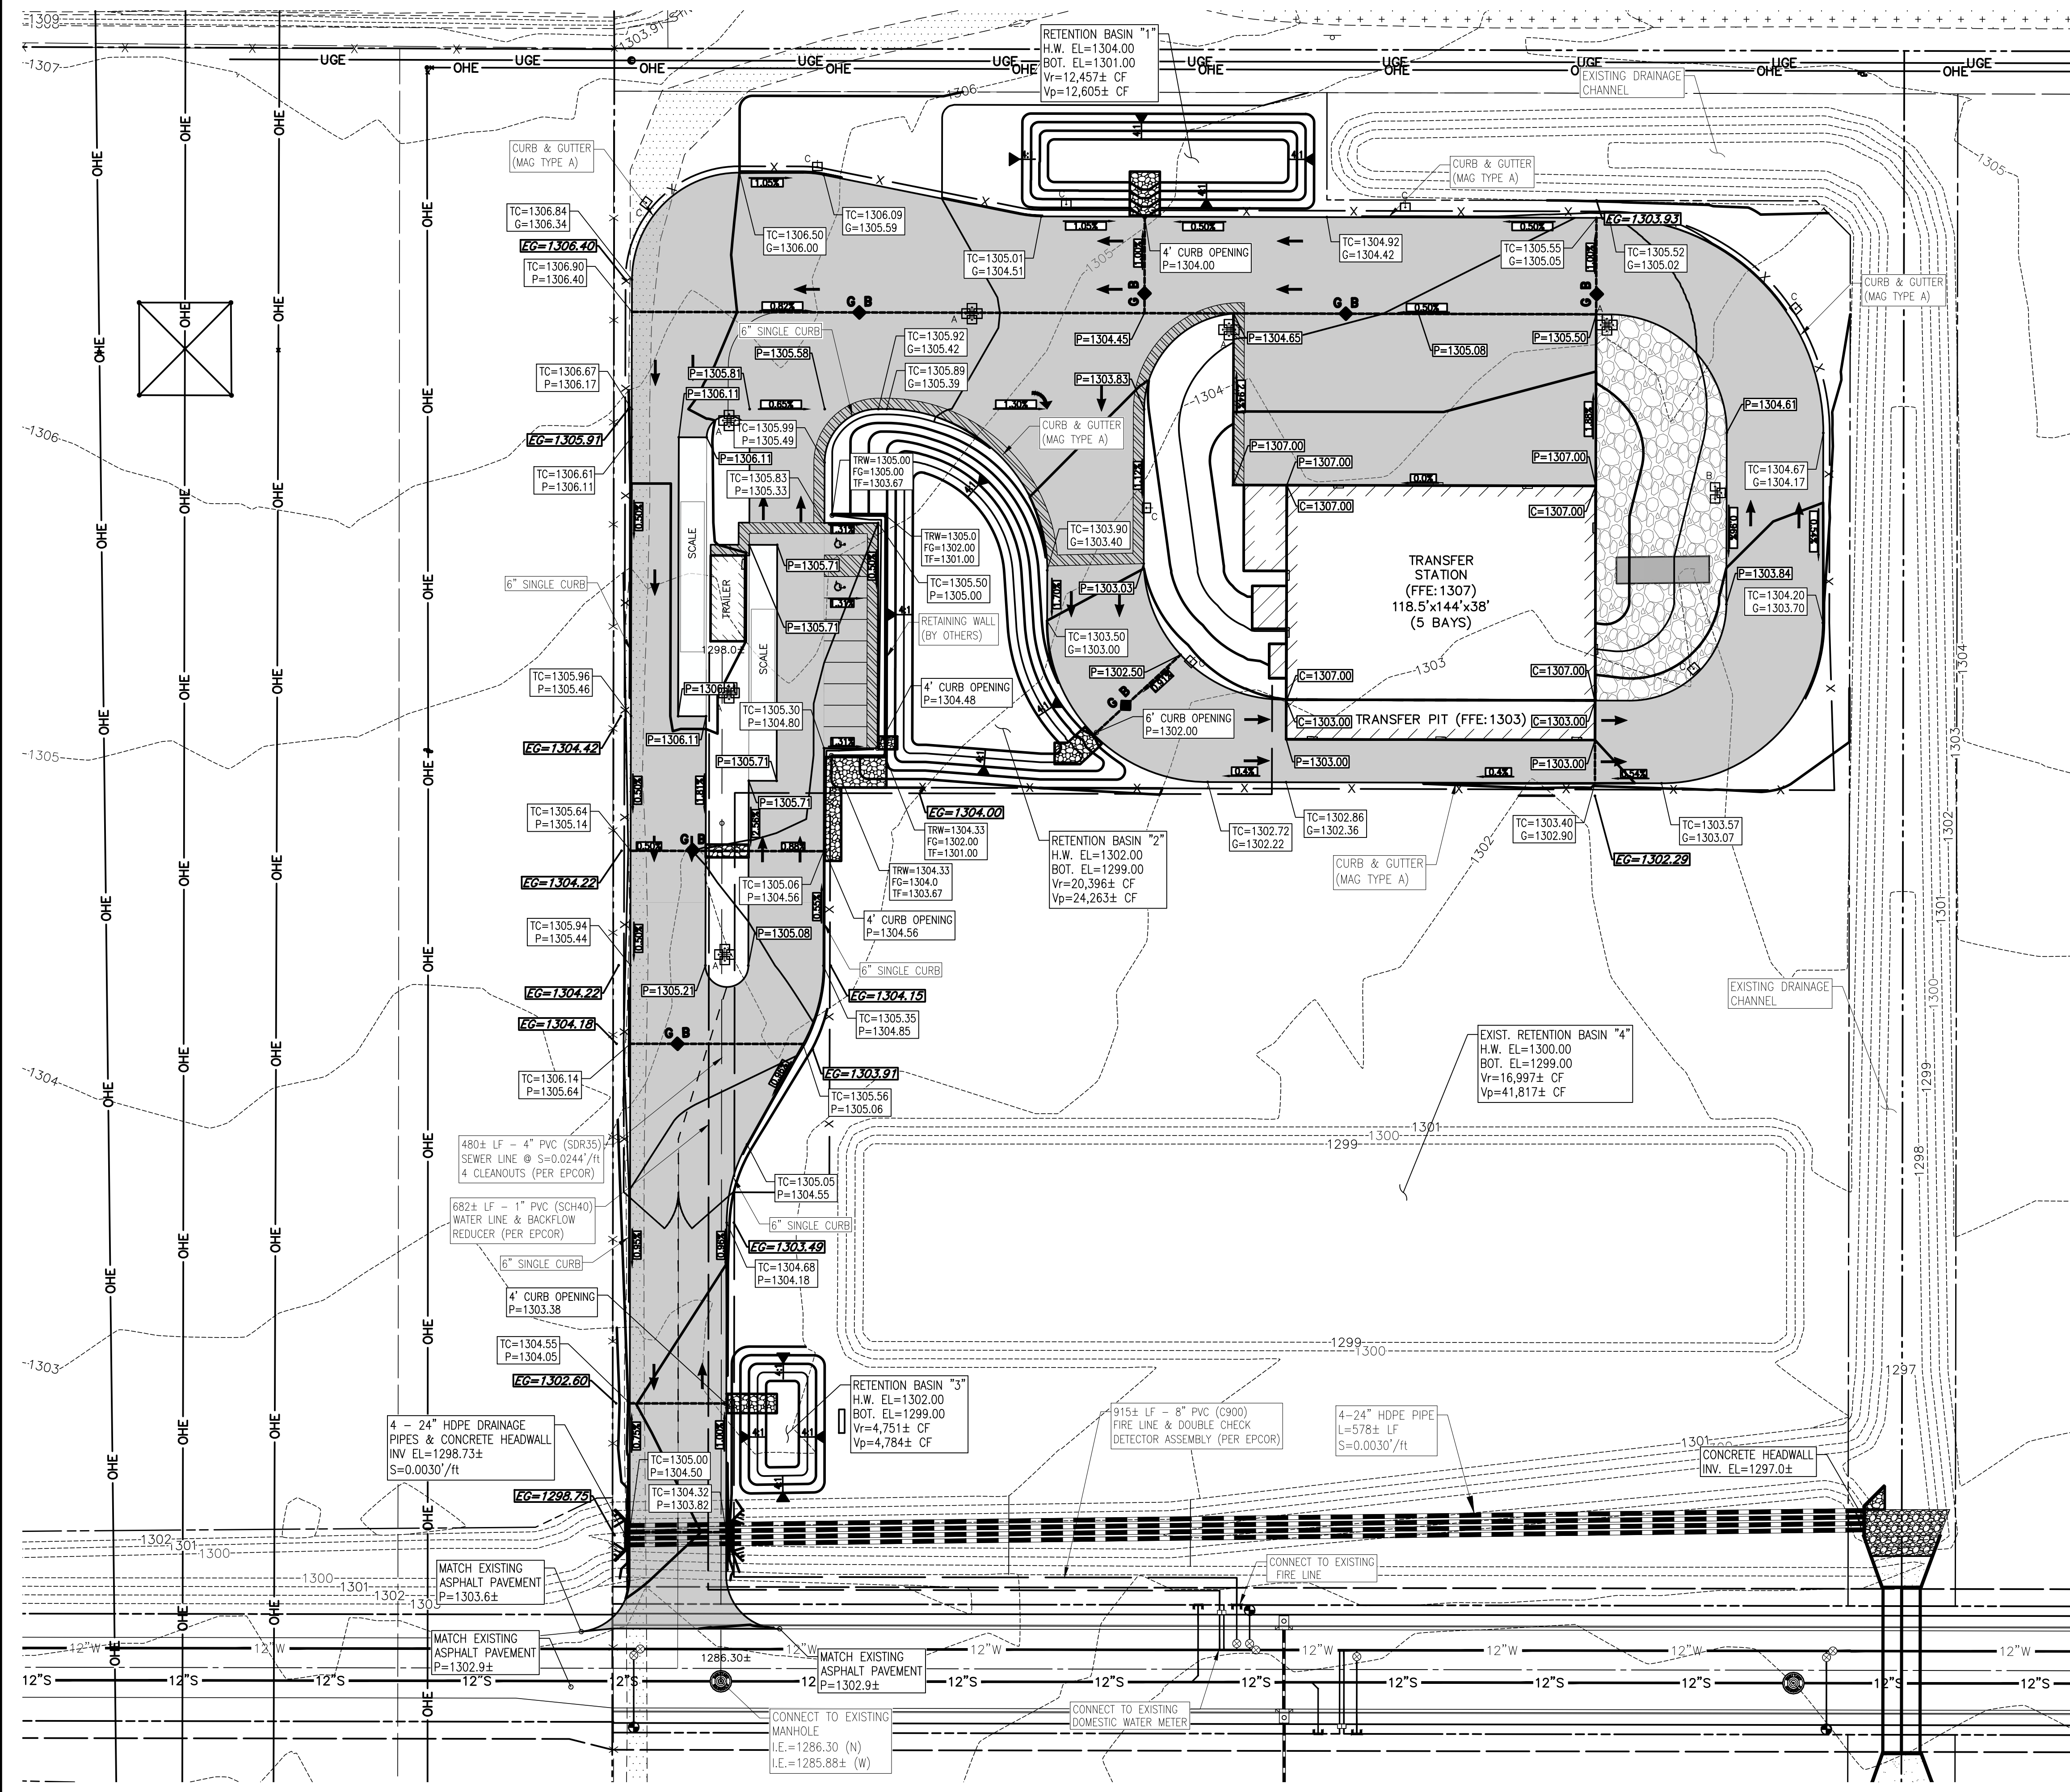

NO.	DATE	COMMENTS

**REPUBLIC SERVICES**  
**WEST WING TRANSFER FACILITY**  
**MARICOPA COUNTY, ARIZONA 85373**

**GRADING AND UTILITY PLAN**

DRAWN BY: SAH  
APPROVED BY: CMS  
PROJECT NUMBER: 12189-073  
DATE PRINTED: 02/AUG/2021  
SHEET NUMBER: C3

ZONING SUBMISSION